



PLAN - TOP SLABS REMOVED

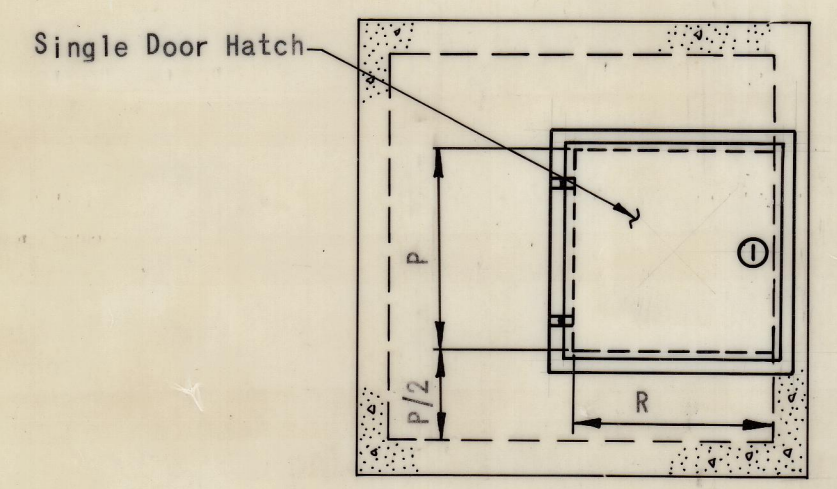

PLAN - TOP SLAB, VALVE VAULT

NOTE:
See Site Plans For Location
Of Odor Filter Units.

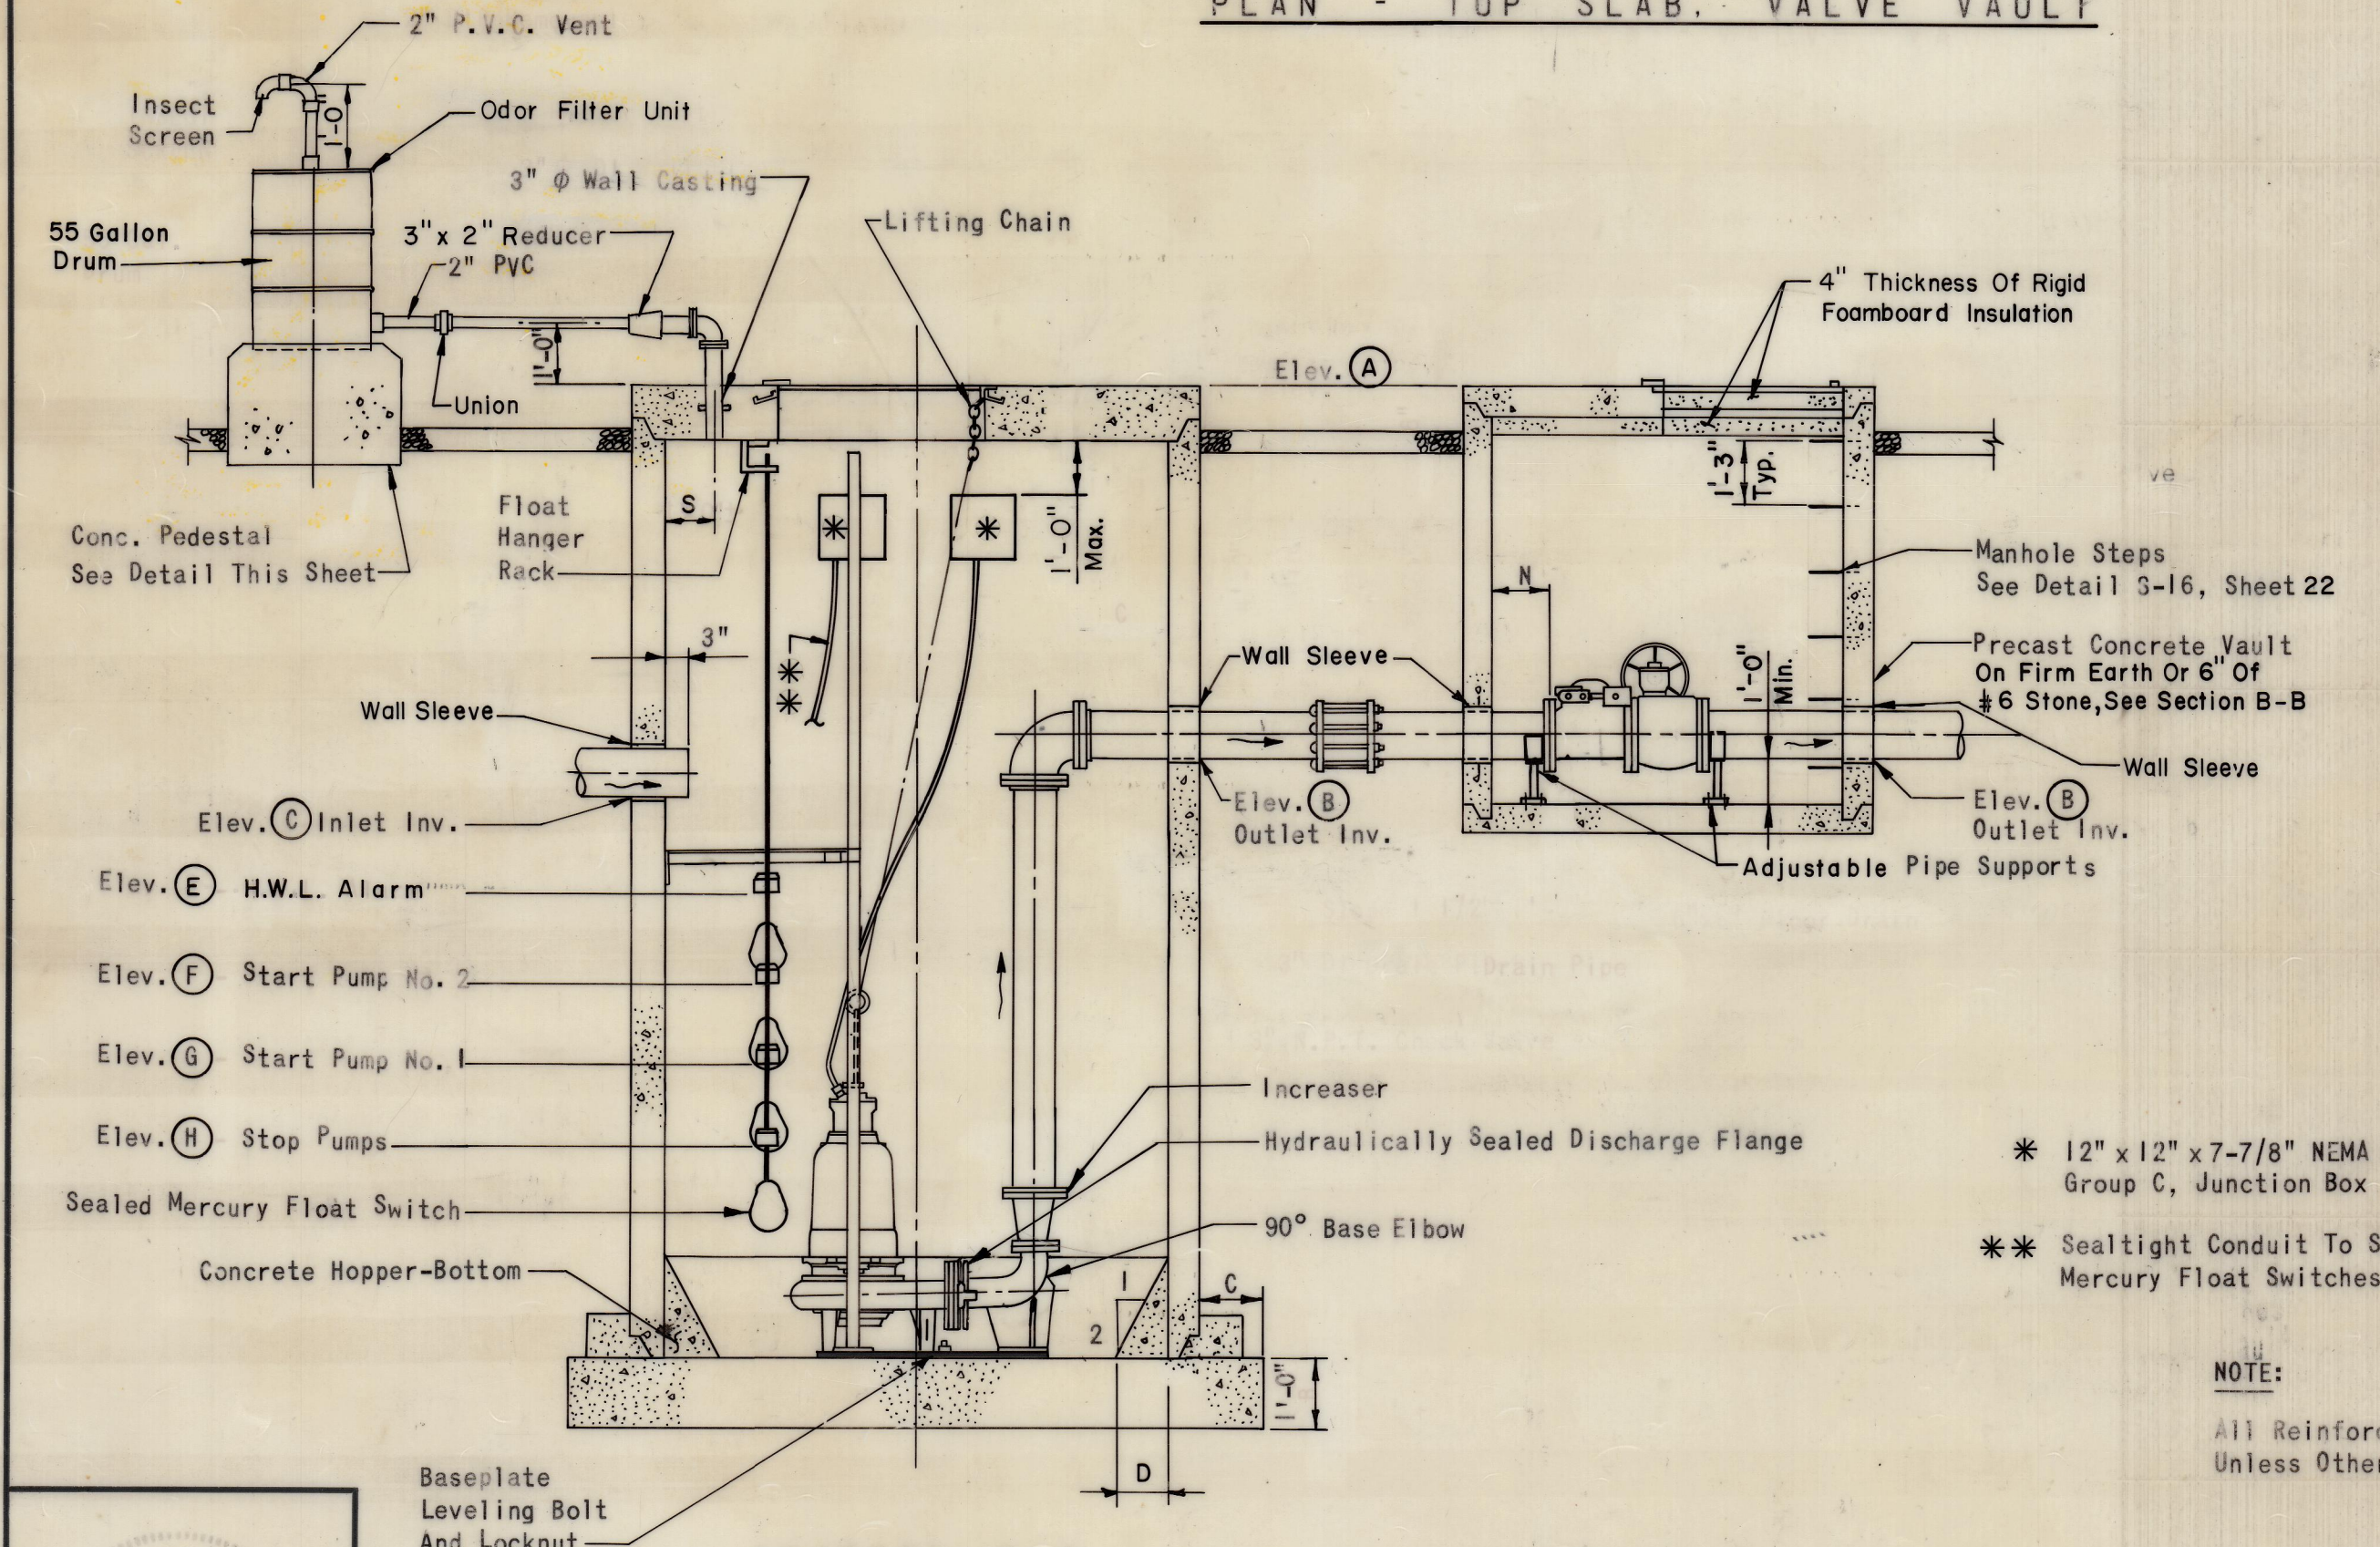


SECTION A-A

PUMPING STATION AND VALVE VAULT DETAILS


No Scale

NOTE:
All Reinforcing 2" Clear
Unless Otherwise Noted.


PUMPING STATION	REFERENCE		ELEVATIONS								DIMENSIONS															
	CON-TRACT	SHEET	A	B	C	D	E	F	G	H	A	B	C	D	E	F	G	H	J	K	L	M	N	P	R	S
2 1-1	1	12	2493.58	2485.00	2486.44	2477.36	2485.44	2484.94	2484.44	2480.19	10'-0"	15"	1'-3"	1'-0"	3'-6"	8'-0"	6'-0"	16"	2'-0"	7'-0"	4'-0"	5'-0"	0'-9"	4'-0"	3'-6"	1'-6"
2 2-1	2	11	2490.50	2484.00	2484.00	2475.67	2483.50	2483.00	2482.50	2478.50	10'-0"	14"	1'-3"	1'-0"	3'-6"	8'-0"	6'-0"	14"	2'-0"	7'-0"	4'-0"	5'-0"	0'-9"	4'-0"	3'-6"	1'-6"
3 1-2-2	2	15	2480.85	2474.00	2469.80	2461.47	2469.30	2468.80	2468.30	2464.30	10'-0"	10"	1'-3"	1'-0"	3'-6"	8'-0"	6'-0"	14"	2'-0"	7'-0"	4'-0"	5'-0"	0'-9"	4'-0"	3'-6"	1'-6"
3 6-1	6	8	2511.67	2507.00	2506.00	2498.67	2505.50	2505.00	2504.50	2501.50	8'-0"	8"	1'-0"	0'-9"	2'-6"	6'-0"	6'-0"	8"	1'-6"	5'-0"	3'-0"	4'-6"	0'-9"	3'-0"	3'-0"	1'-3"
4 3-2	3	12	2470.50	2463.00	2464.00	2456.17	2463.00	2462.50	2462.00	2459.00	8'-0"	10"	1'-0"	0'-9"	3'-0"	6'-0"	6'-0"	10"	1'-6"	6'-0"	3'-6"	4'-6"	0'-9"	3'-0"	3'-0"	1'-0"
4 6-2	6	12	2478.00	2468.70	2460.08	2452.75	2459.58	2459.08	2458.58	2455.58	8'-0"	8"	1'-0"	0'-9"	2'-6"	6'-0"	6'-0"	8"	1'-6"	5'-0"	3'-0"	4'-6"	0'-9"	3'-0"	3'-0"	1'-3"
3 1-1	1	8	2502.50	2497.10	2495.70	2486.97	2491.80	2491.30	2493.20	2489.80	6'-0"	8"	1'-0"	0'-9"	2'-6"	6'-0"	6'-0"	8"	1'-6"	5'-0"	3'-0"	4'-6"	0'-9"	3'-0"	3'-0"	1'-3"
5 1-1	5	6	2490.50	2484.63	2484.63	2478.10	2483.13	2483.33	2483.13	2480.93	6'-0"	8"	1'-0"	0'-6"	2'-3"	6'-0"	4'-0"	6"	1'-4"	4'-0"	3'-0"	4'-6"	0'-6"	3'-0"	3'-0"	0'-8"

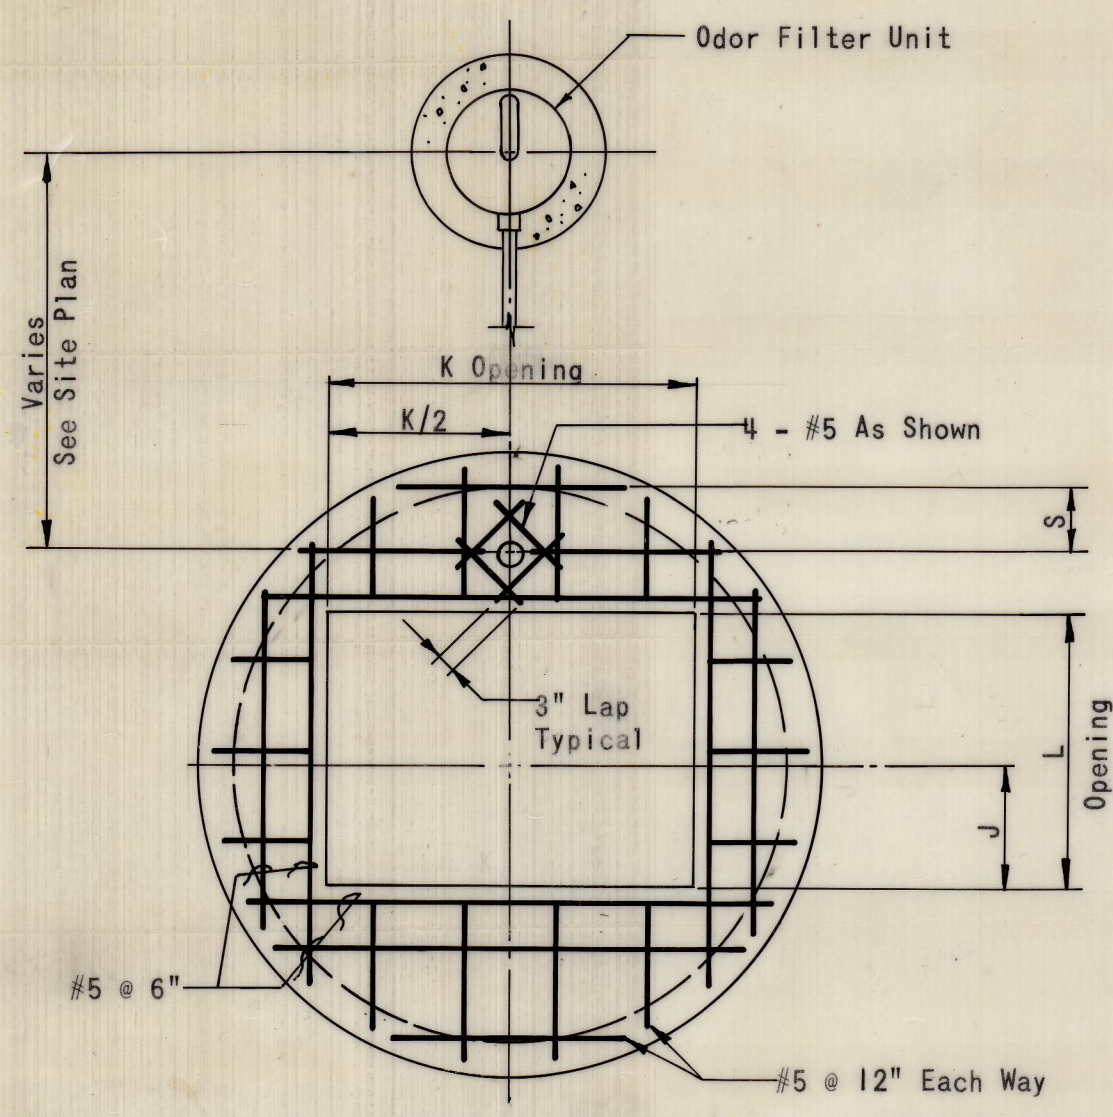

PLAN - TOP SLAB, PUMPING STATION

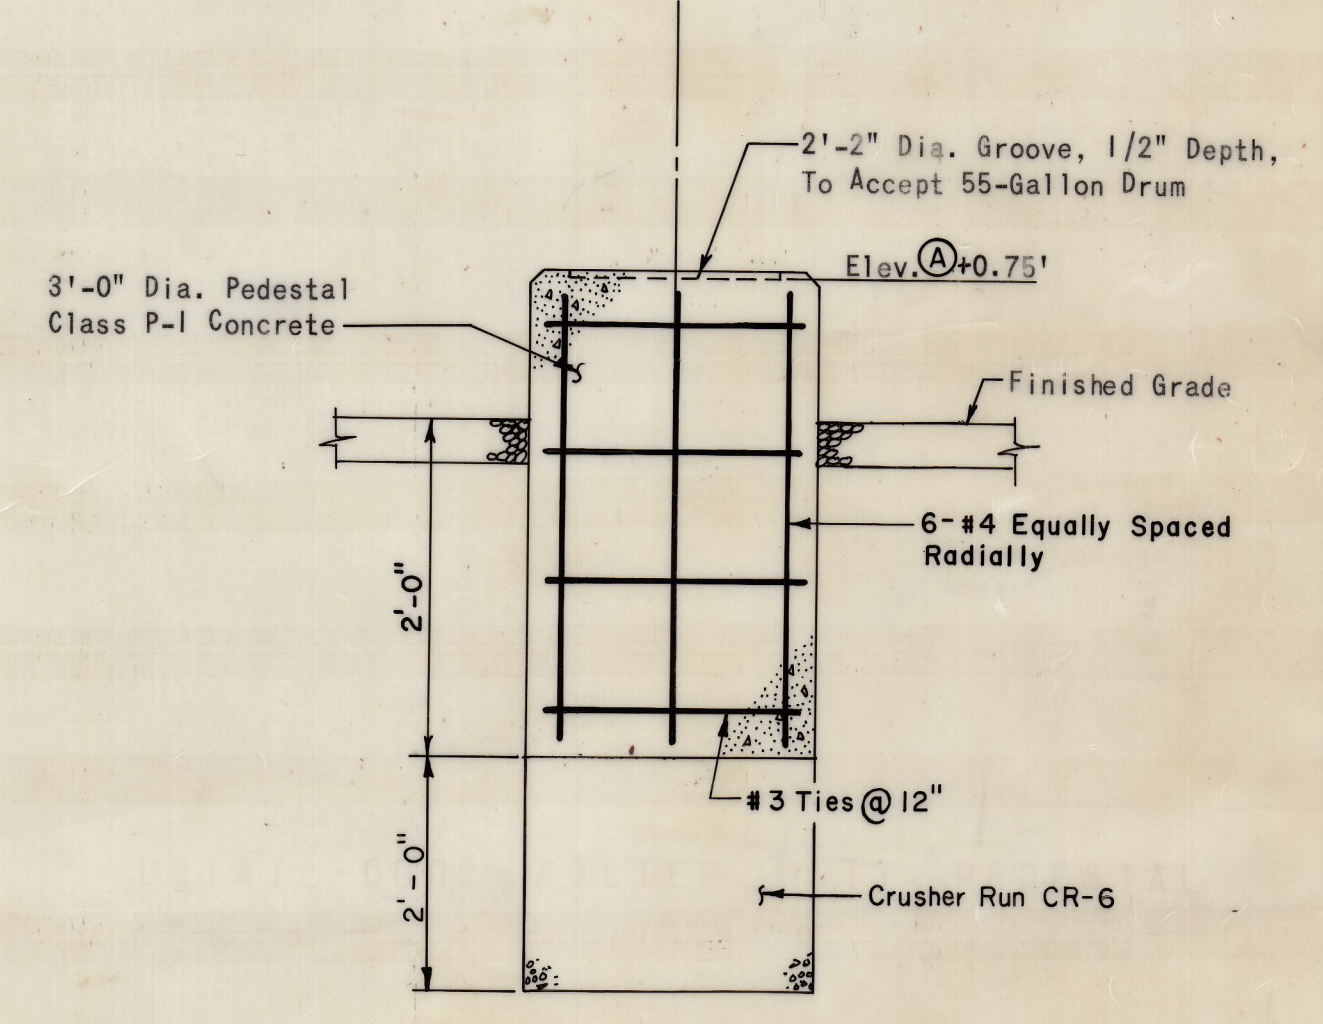

DETAIL - ODOR FILTER UNIT PEDESTAL

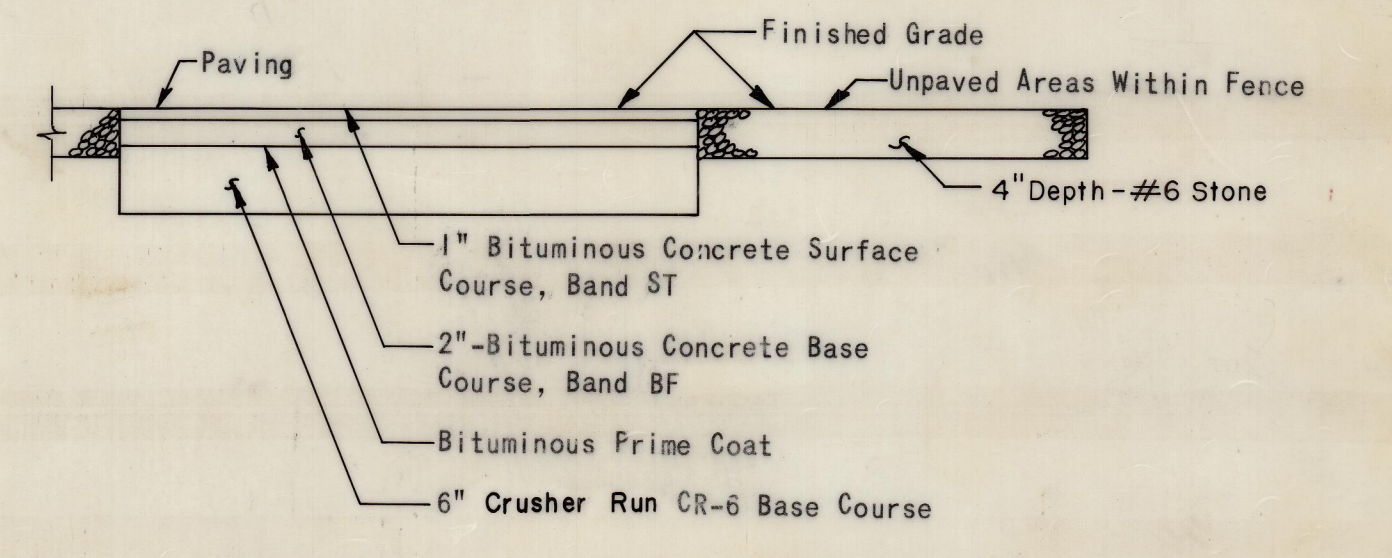

TYPICAL PAVING SECTION

No Scale

CONTRACT DRAWINGS

ISSUED FEB 20 1982

DATE	REVISION	BY
5-20-83	Revised P.S. 2-2	B.S.
5-16-83	Revised P.S. 2-2 & 2-2 P.C.C.	P.C.C.
10-1-83	Revised P.S. 2-2 & 2-2 P.C.C.	P.C.C.
5-11-82	Revised Paving Section 1415 & 1416	K.P.
2-20-82	Revised Paving Section 1415 & 1416	P.C.C.

SCALE	POSITION SHEET	SHEET NO.
AS SHOWN	6	OF 25




RUMMEL, KLEPPER & KAHL
CONSULTING ENGINEERS
BALTIMORE, MARYLAND

ENGINEER
REG. NO. 3381
DATE FEB 25 1982
DESIGNED
DRAWN
CHECKED

PROJECT C-240565-03
DEEP CREEK LAKE SANITARY
DISTRICT SEWERAGE FACILITIES


CONTRACT NO. 10
PUMPING STATIONS

DUPLY - SUBMERSIBLE
PUMPING STATION DETAILS

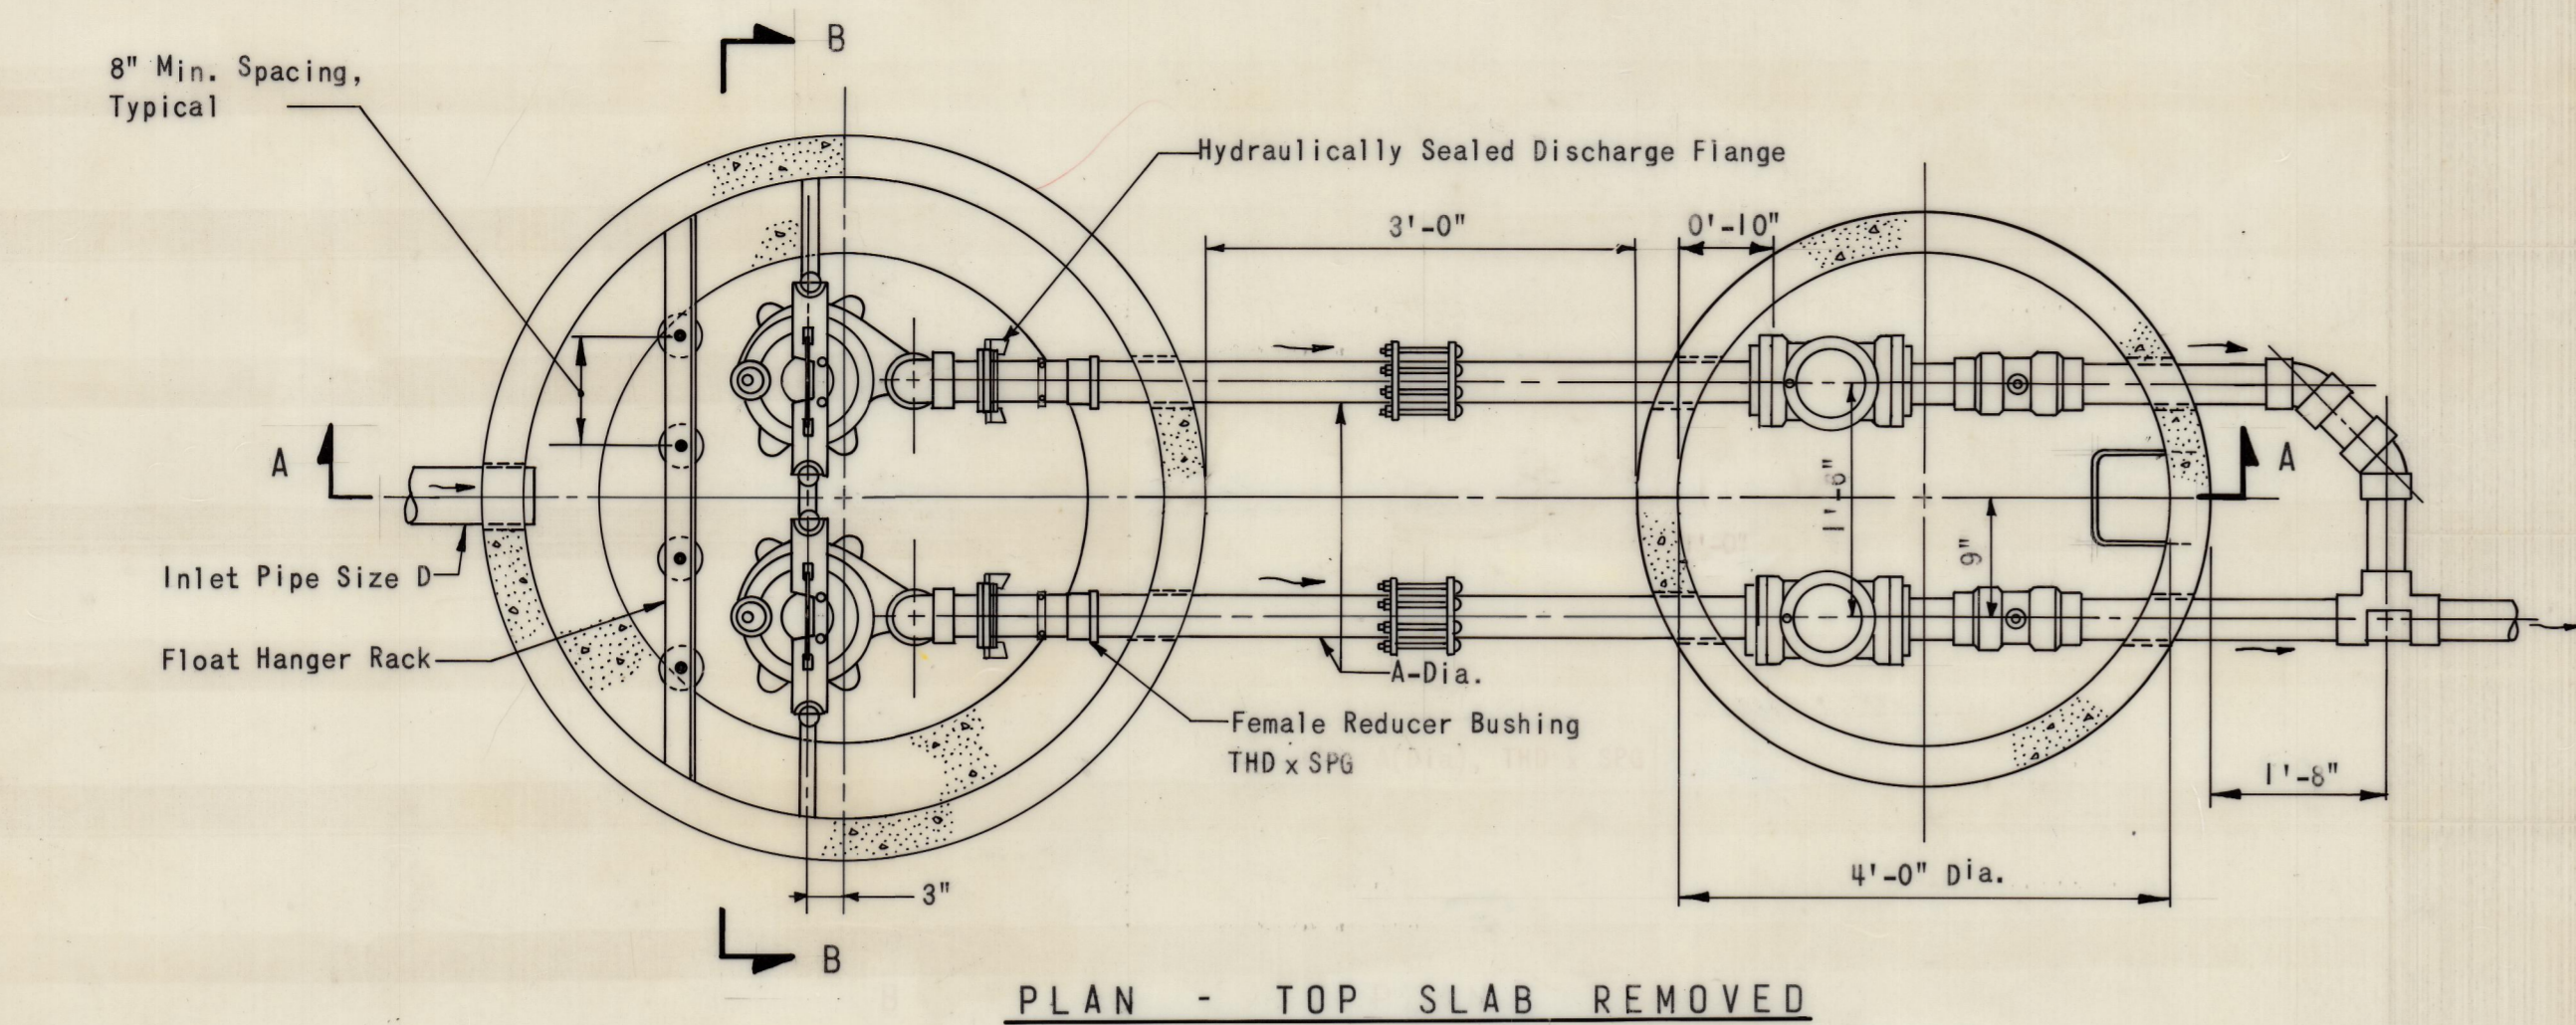

PLAN - TOP SLAB REMOVED


NOTE:
See Site Plans For Location
Of Odor Filter Unit

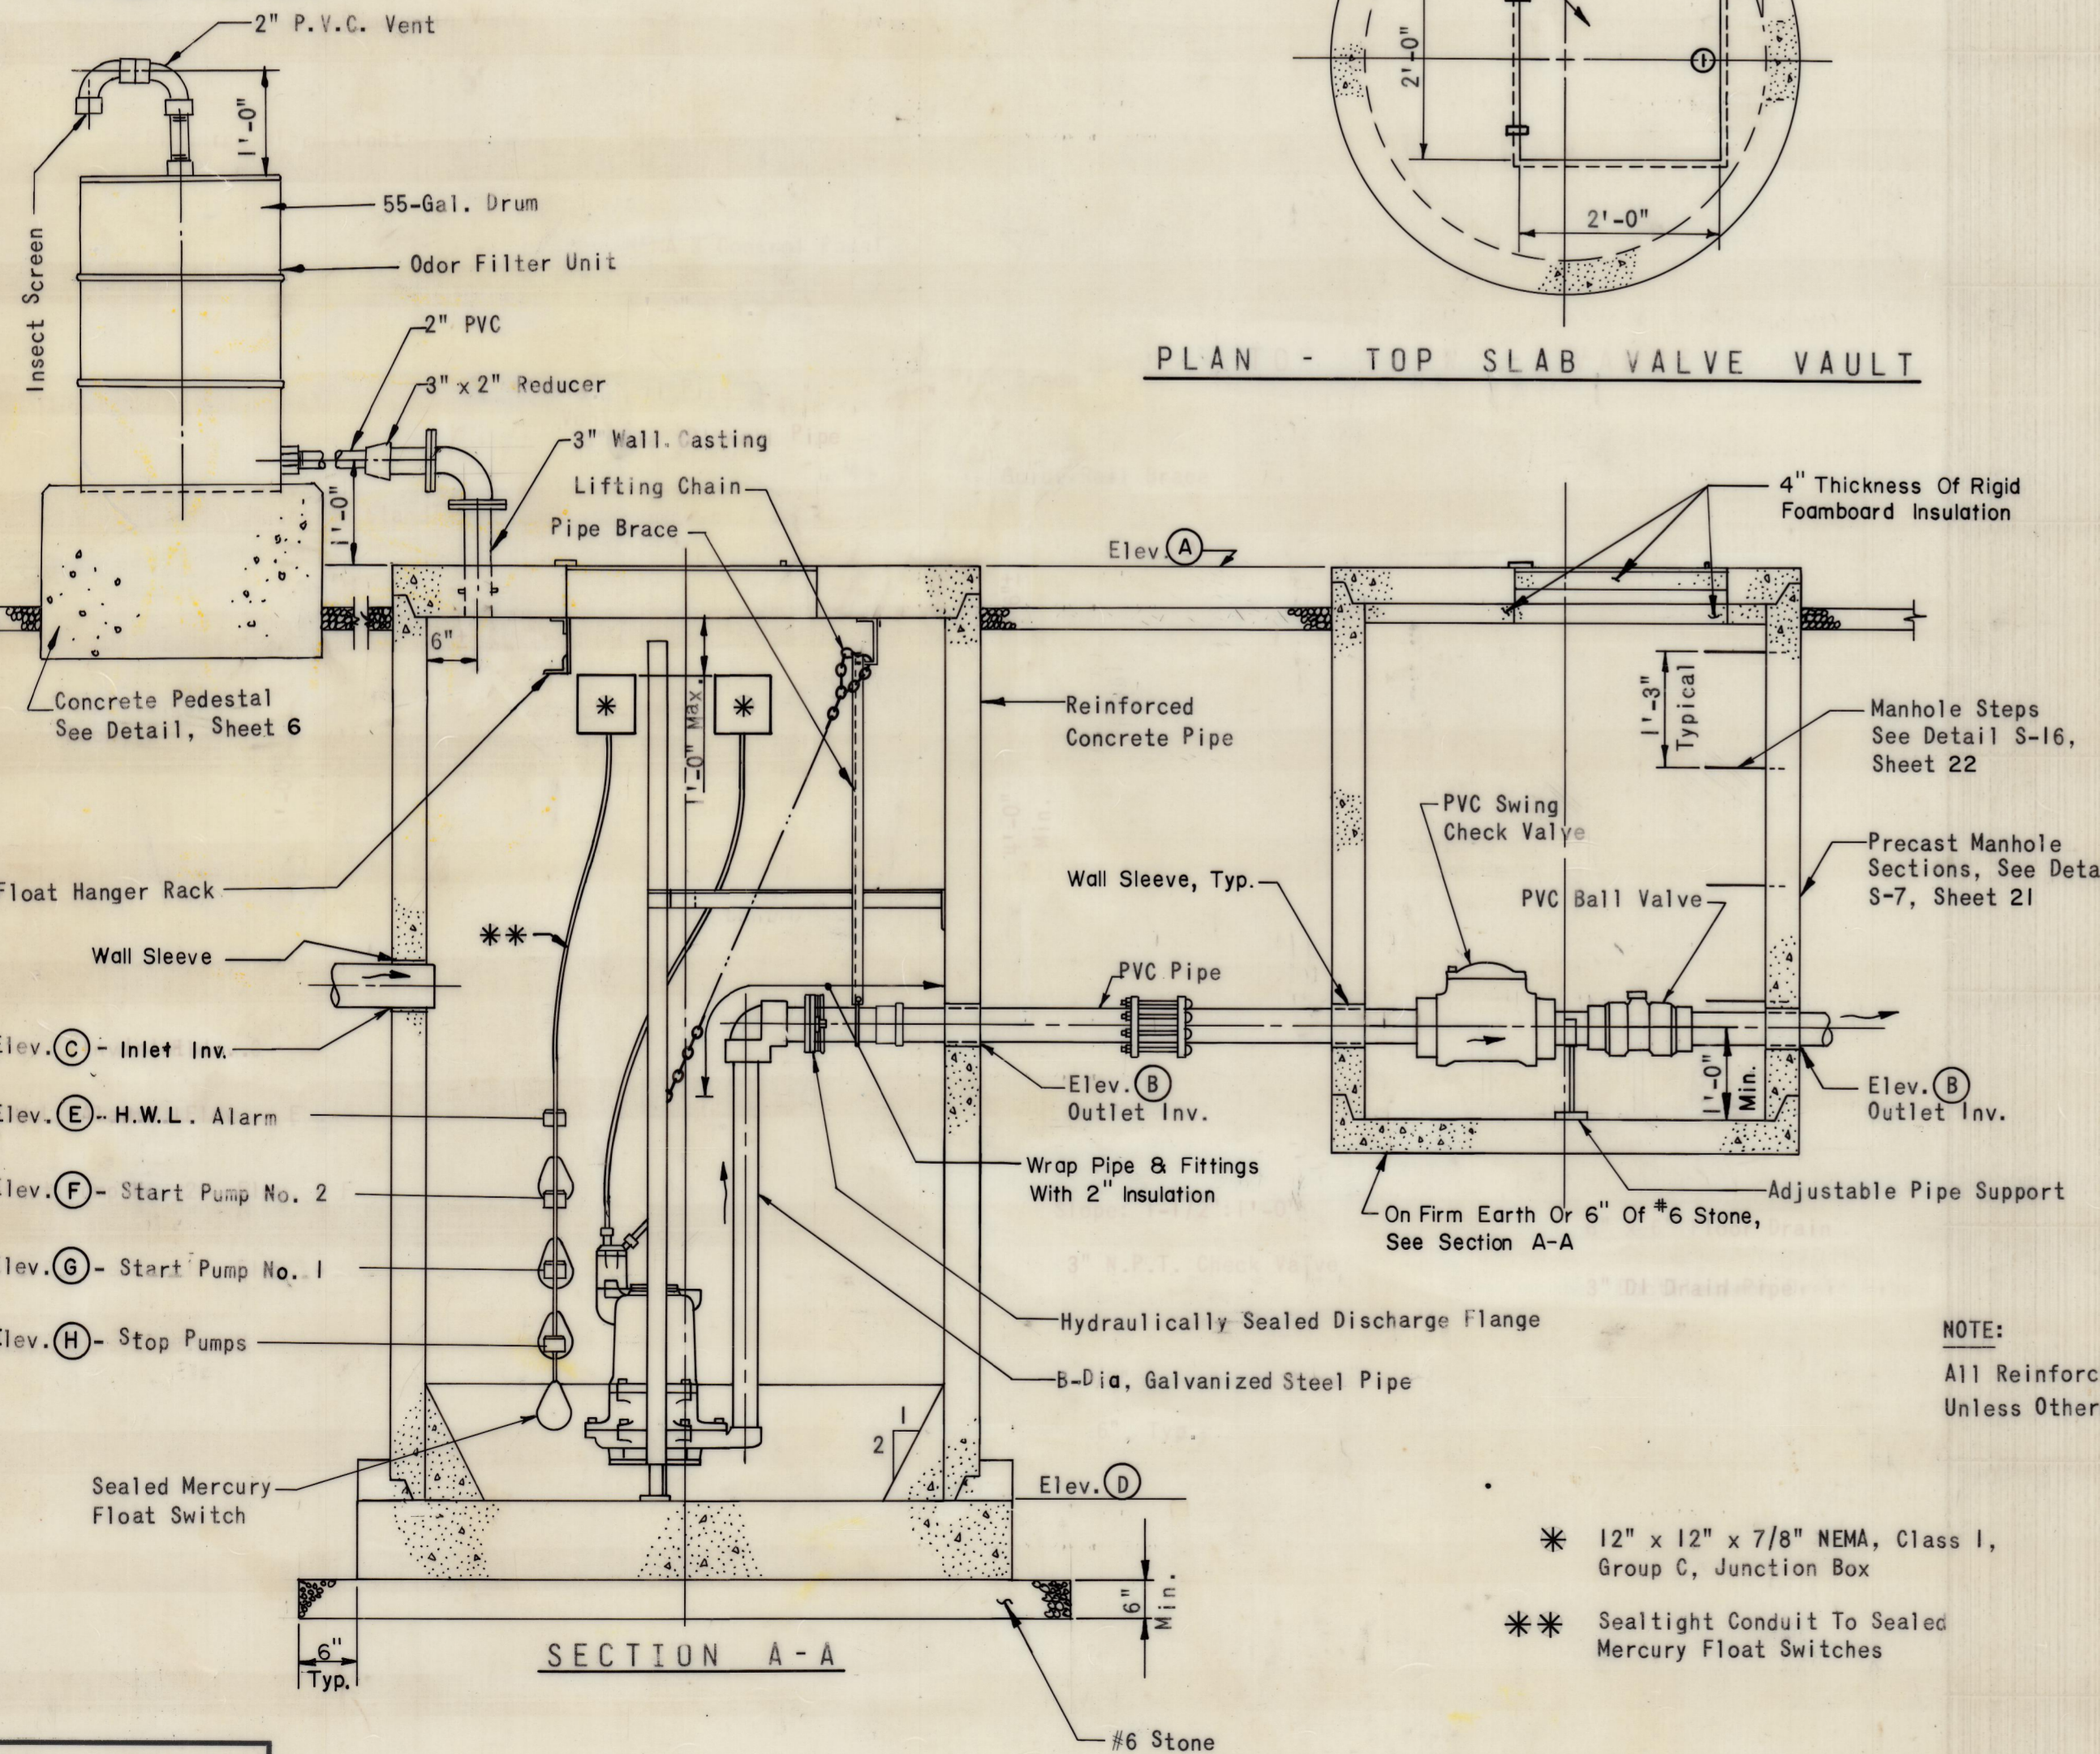


SECTION A-A

PUMPING STATION AND VALVE VAULT DETAILS

No Scale

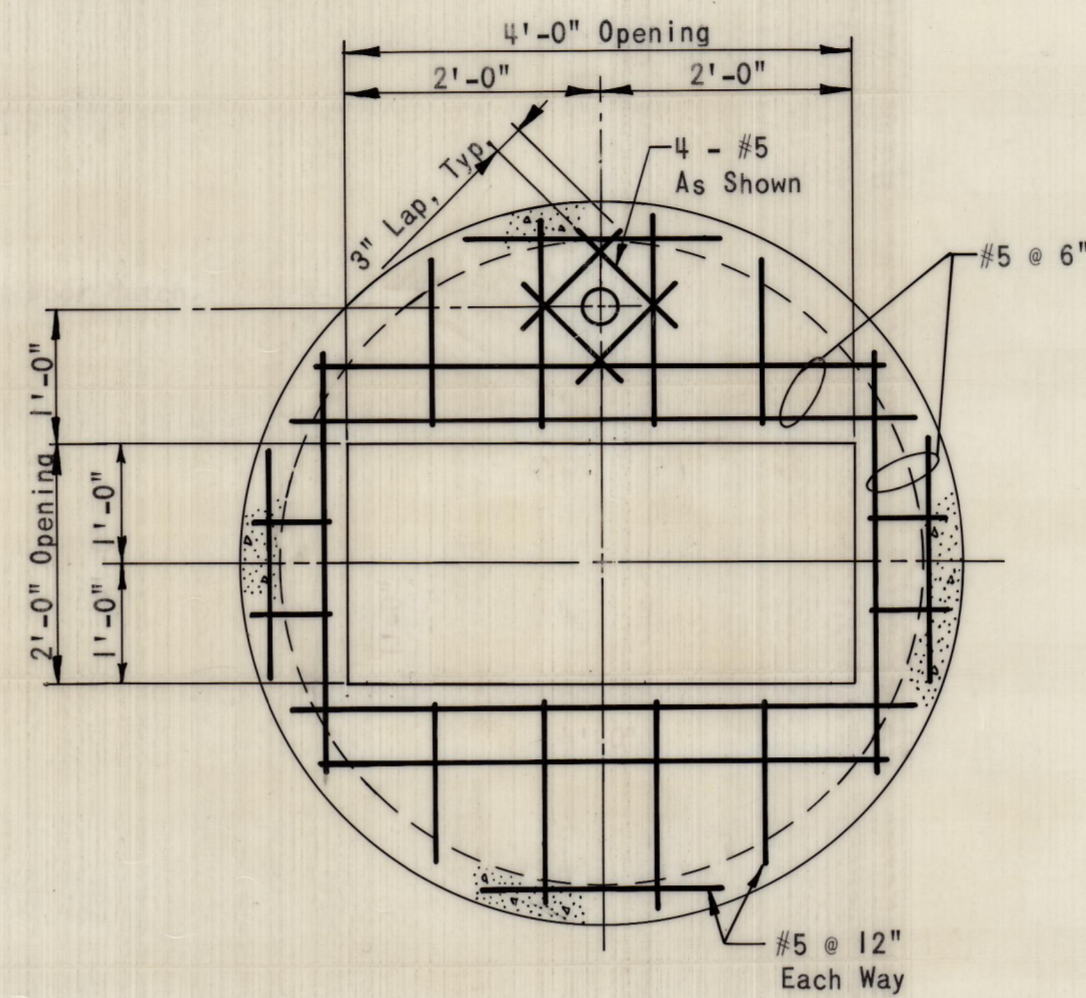

PLAN - TOP SLAB, PUMPING STATION

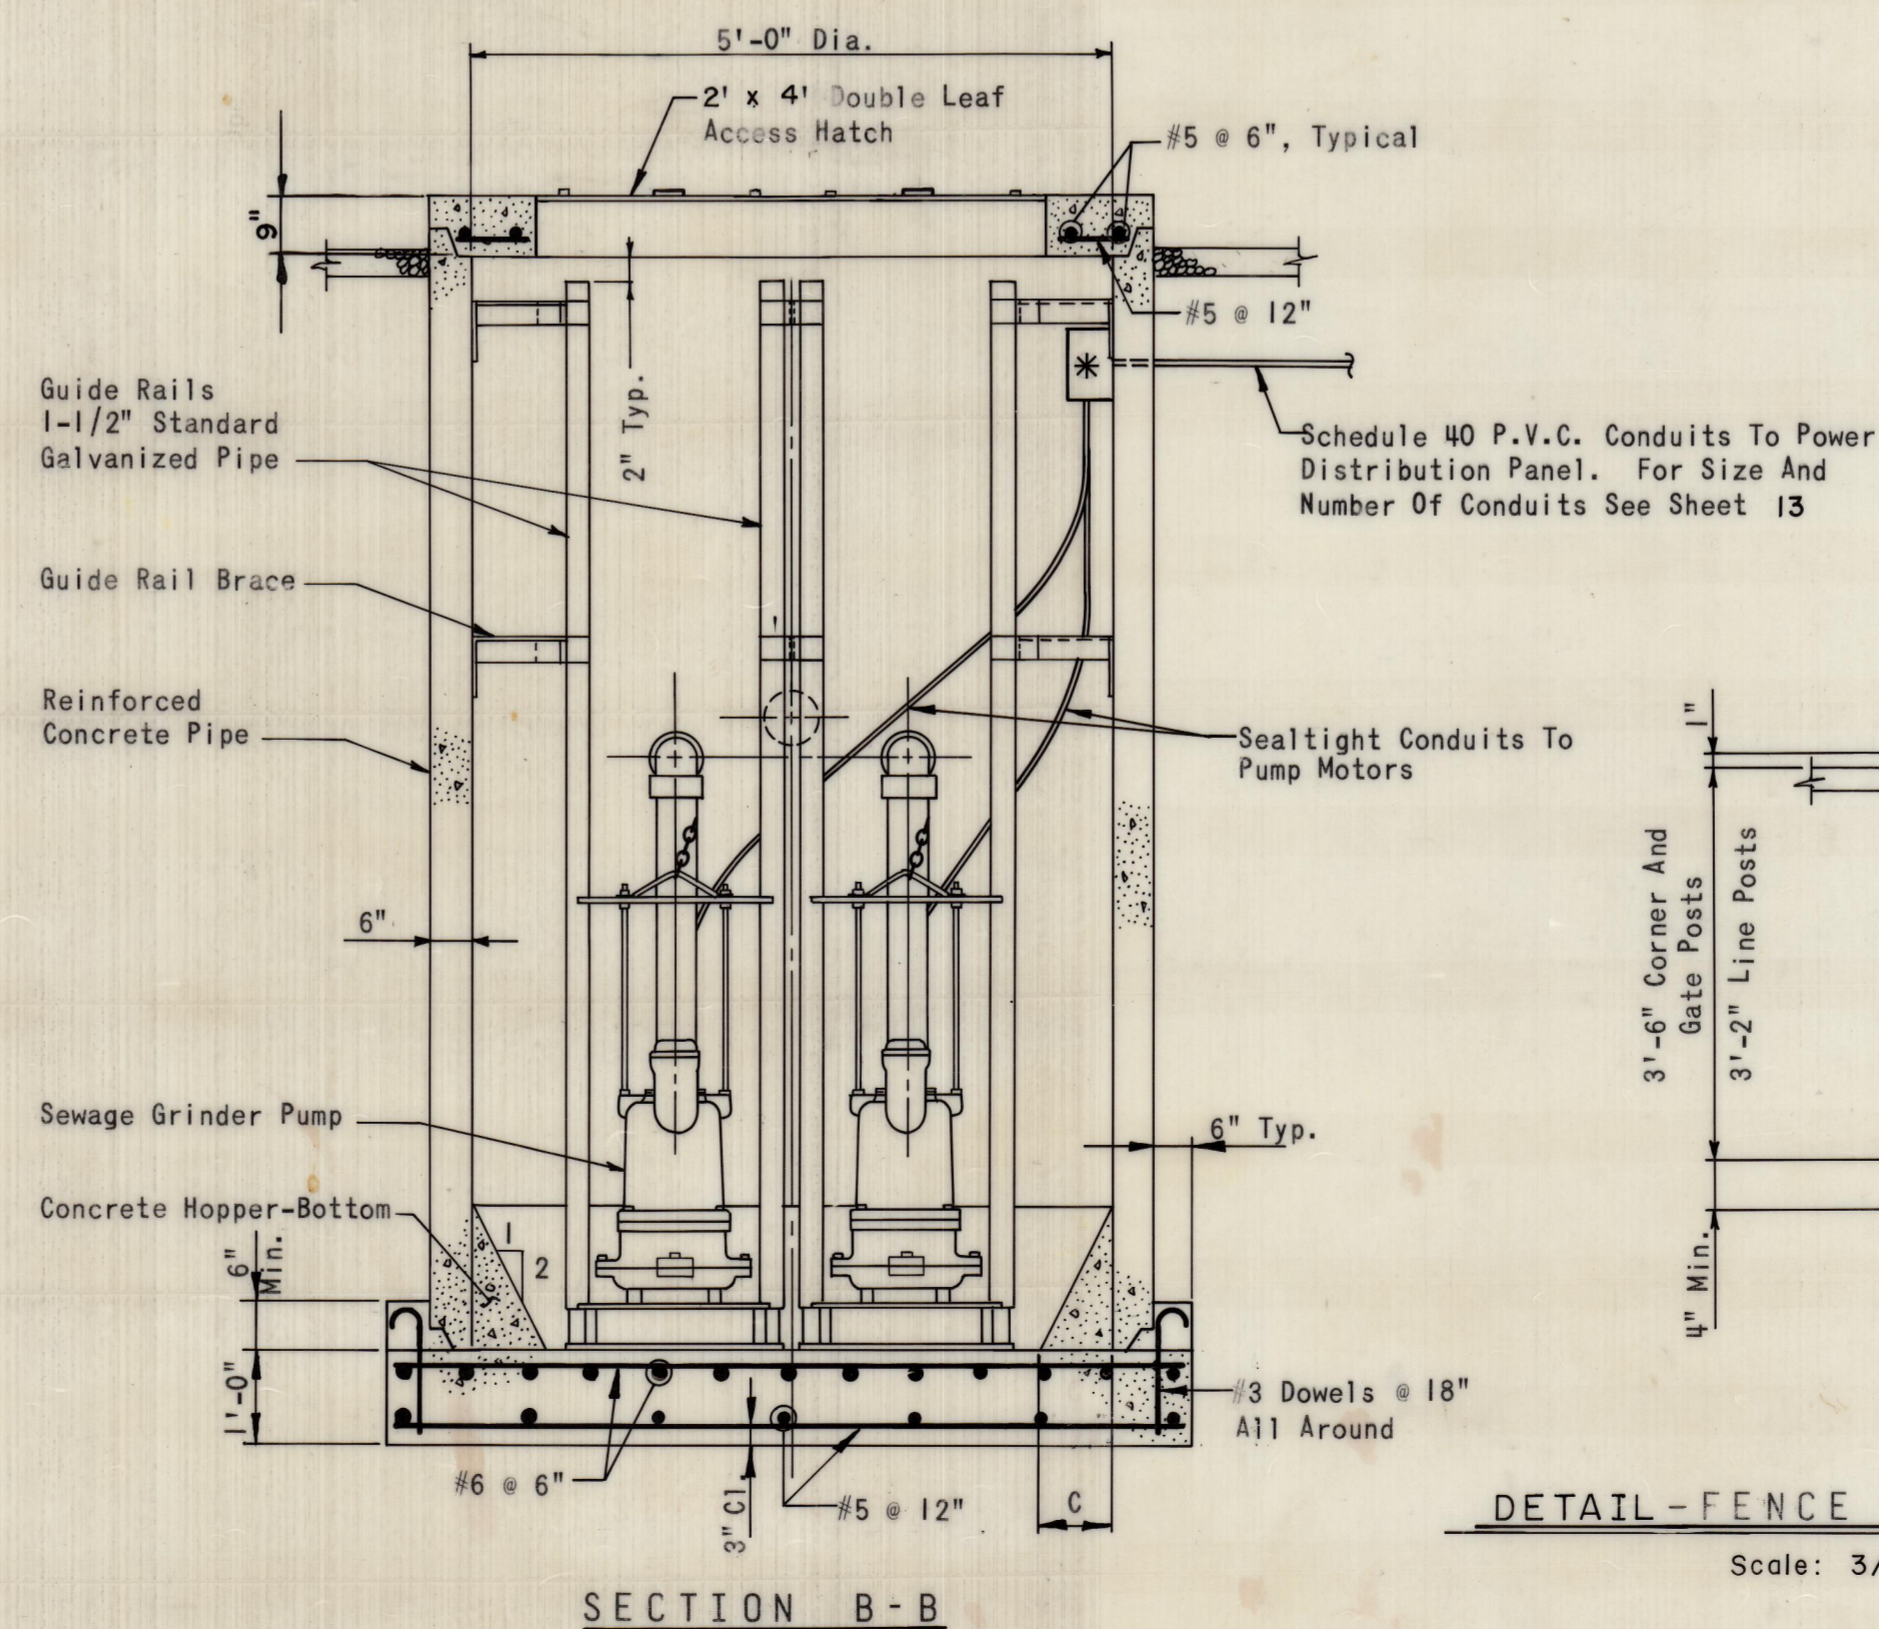

SECTION B-B

DETAIL - FENCE POST FOOTING

Scale: 3/4" = 1'-0"

DETAIL - GUARD POSTS

Scale: 3/4" = 1'-0"

PUMPING STATION	REFERENCE		ELEVATIONS								DIMENSIONS					
	CON-TRACT	SHEET	A	B	C	D	E	F	G	H	A	B	C	D		
1	3-1	3	5	2485.33	2479.61	2465.02	2462.52	2464.02	2463.52	2463.02	2462.02	1 1/2"	1 1/4"	1'-0"	8"	
2	7-1	7	5	2494.67	2488.50	2488.50	2484.00	2487.50	2486.50	2485.50	2484.50	3"	2"	0'-9"	2 1/2"	
3	1	7-2	7	8	2482.50	2473.00	2472.00	2468.00	2471.00	2470.00	2469.00	2468.50	2 1/2"	2"	0'-9"	2 1/2" Or 3"
2	3-2	8	11	2535.30	2635.00	2631.00	2627.00	2630.50	2629.50	2628.50	2627.50	2"	1 1/4"	1'-0"	2 1/2" Or 3"	
2	8-1	8	7	2485.50	2476.00	2476.80	2474.80	2477.80	2476.80	2476.30	2475.30	3"	2"	0'-9"	2 1/2"	



RUMMEL, KLEPPER & KAHL
CONSULTING ENGINEERS
BALTIMORE, MARYLAND

ENGINEER: *[Signature]*
REG. NO. 3381
DESIGNED: _____
DRAWN: _____
DATE: FEB 25 1967
CHECKED: _____

PROJECT C-240565-03
DEEP CREEK LAKE SANITARY
DISTRICT SEWERAGE FACILITIES

CONTRACT NO. 10
PUMPING STATIONS

HIGH CAPACITY DUPLEX GRINDER
PUMPING STATION DETAILS


SCALE AS SHOWN
POSITION SHEET
SHEET NO. 7 OF 25

CONTRACT DRAWINGS


ISSUED FEB 26 1967

NO.	DATE	REVISION	BY
1	5-10-62	Revised P.S. 7-2 Elev.	E.M.S.
2	10-1-62	Revised P.S. 7-1 Elev.	E.M.S.
3	5-10-62	Revised P.S. 8-1 Elev. & 8-2 Elev.	J.K.P.
4	5-10-62	Revised P.S. 8-1 Elev. & 8-2 Elev.	R.F.


DRAWING COMPLETED

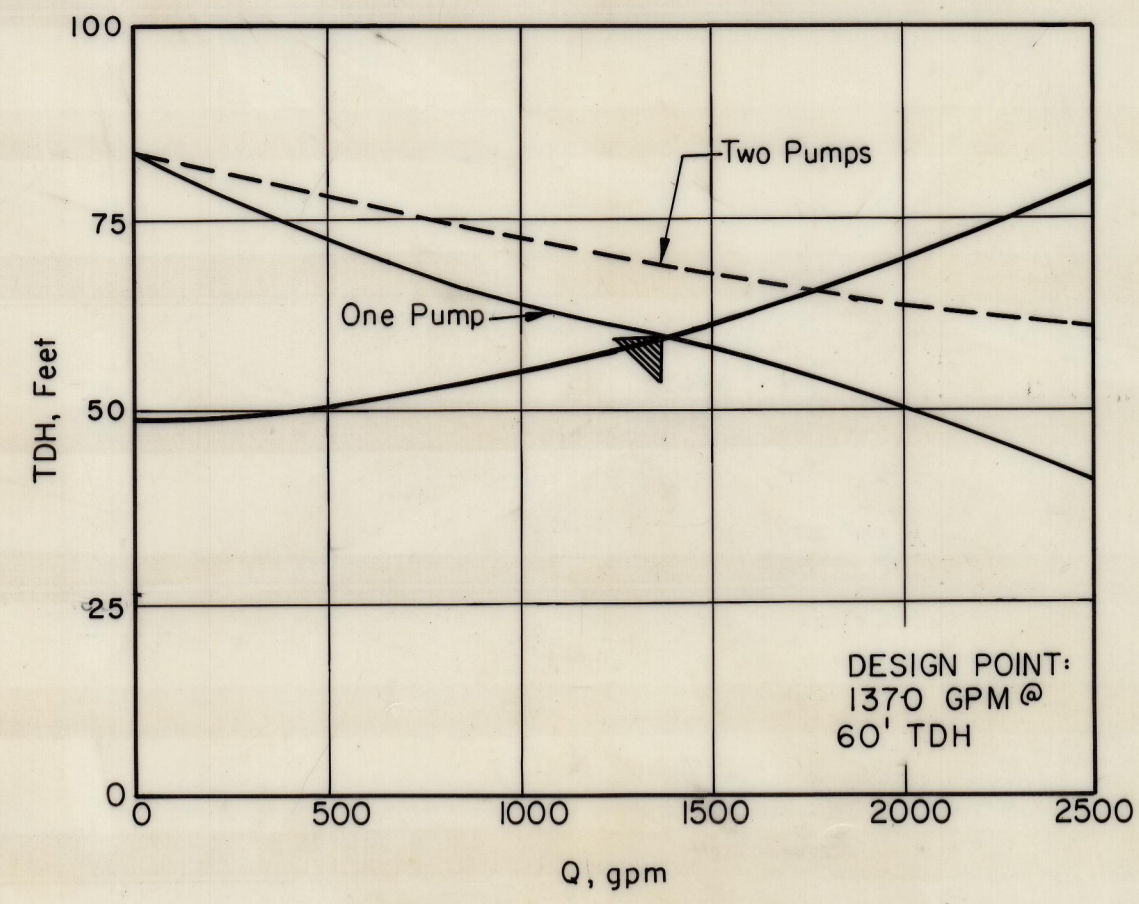


PUMPING STATION NO. 1-1

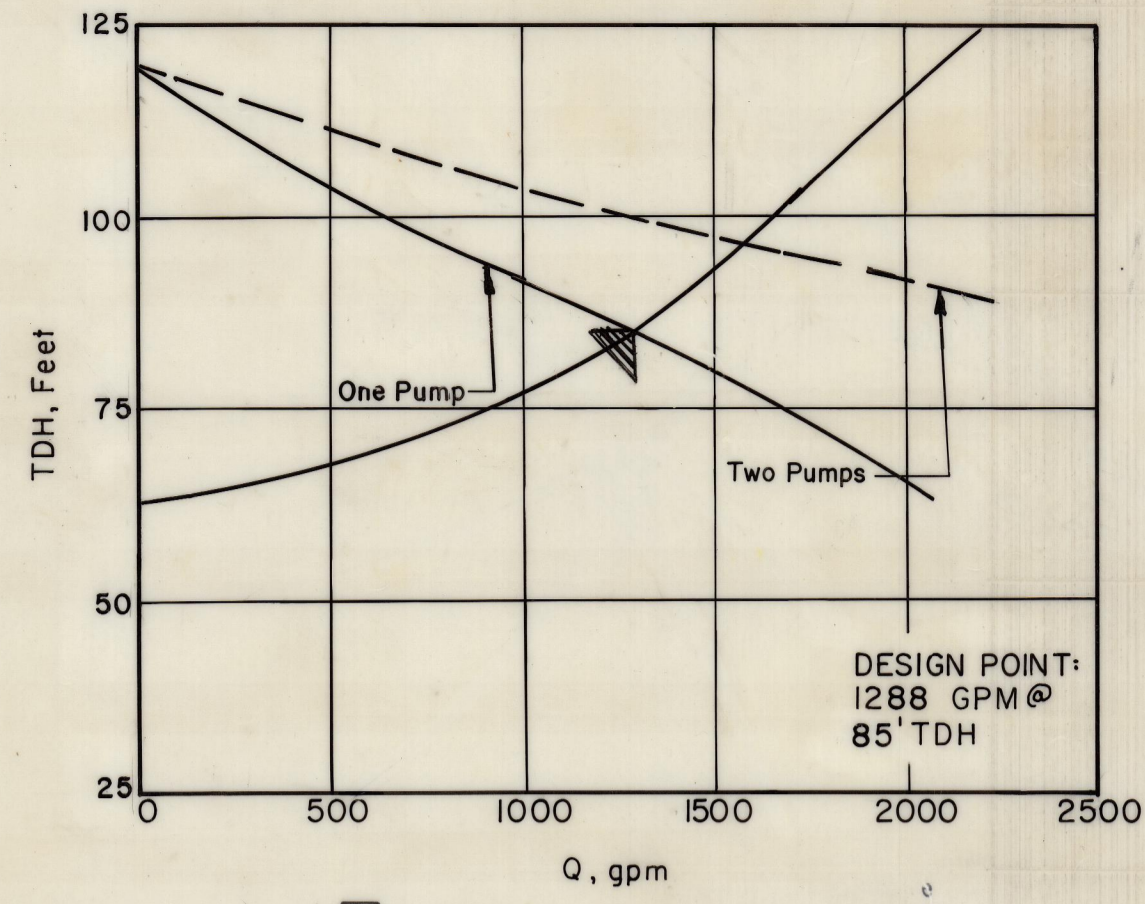


PUMPING STATION NO. 2-1

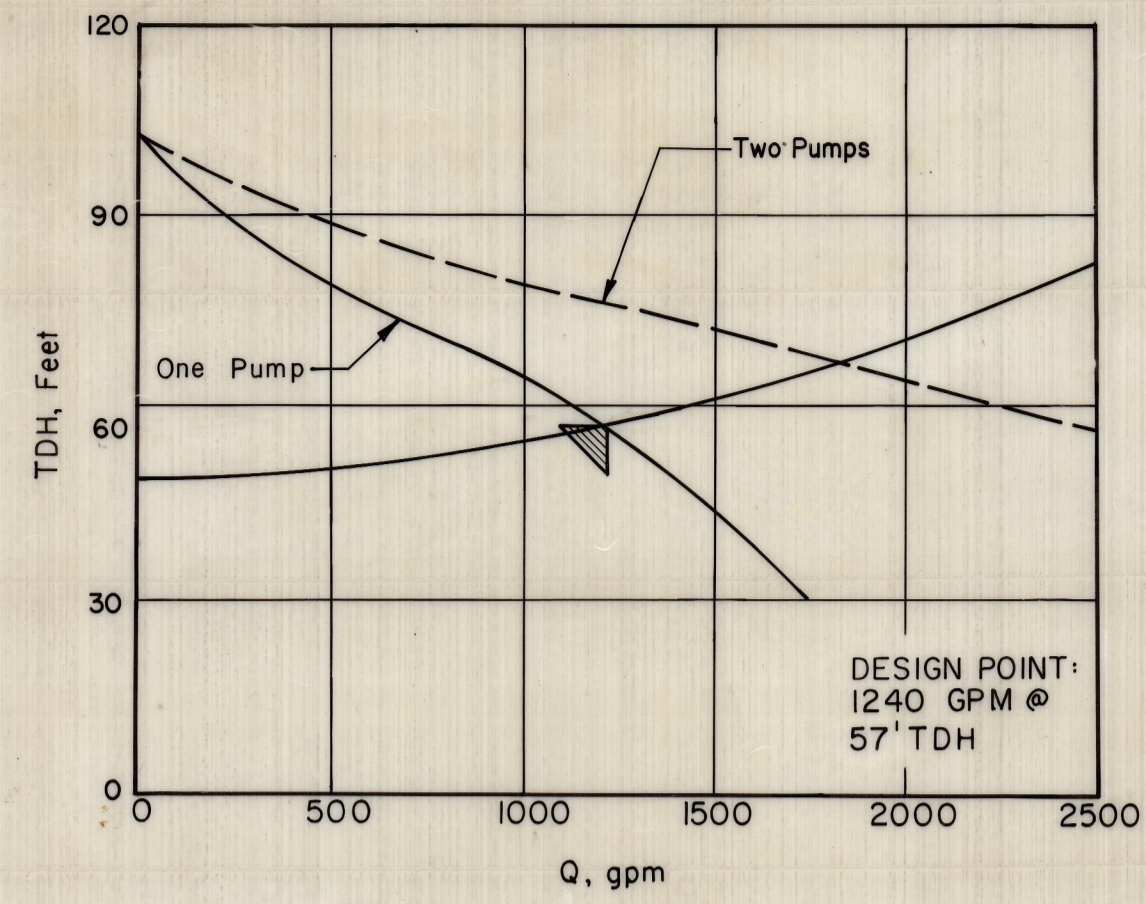


PUMPING STATION NO. 2-2

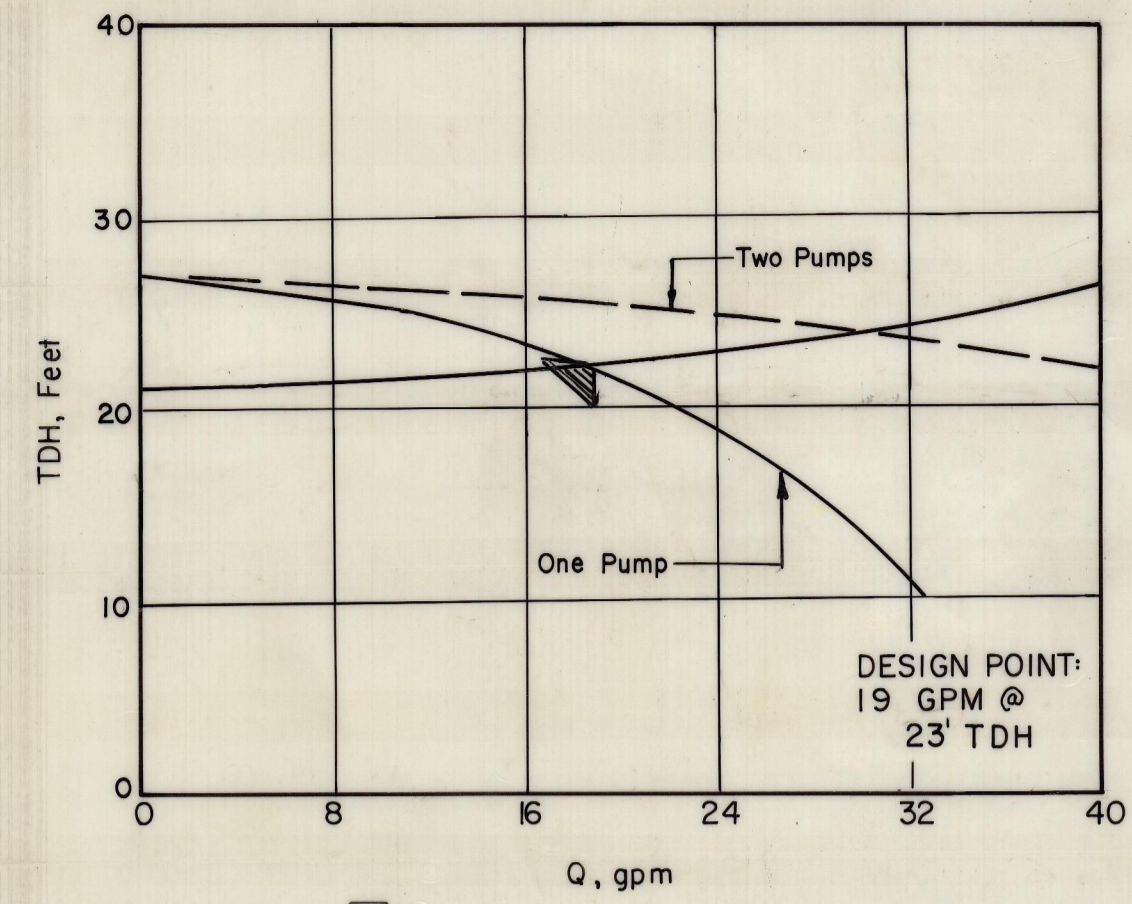


PUMPING STATION NO. 3-1

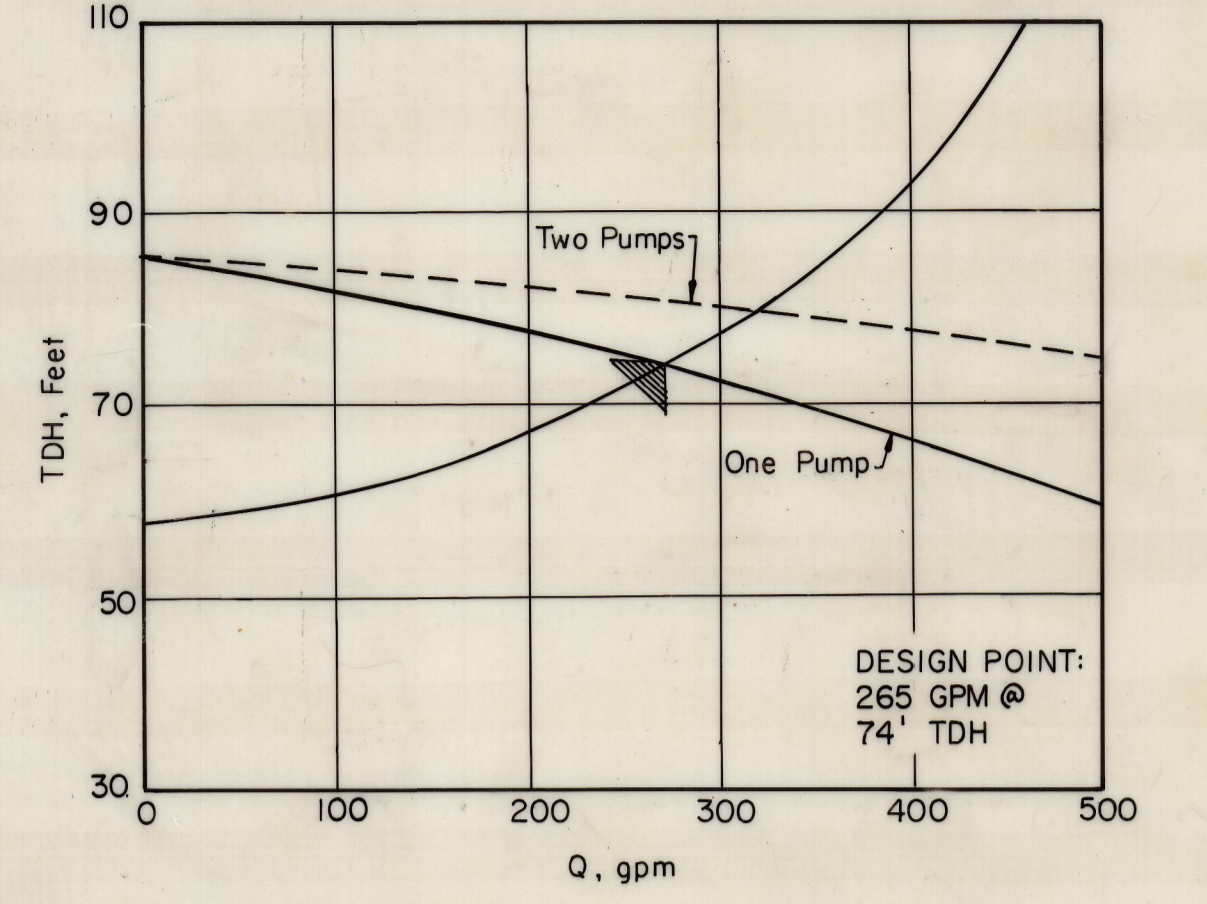


PUMPING STATION NO. 5-1

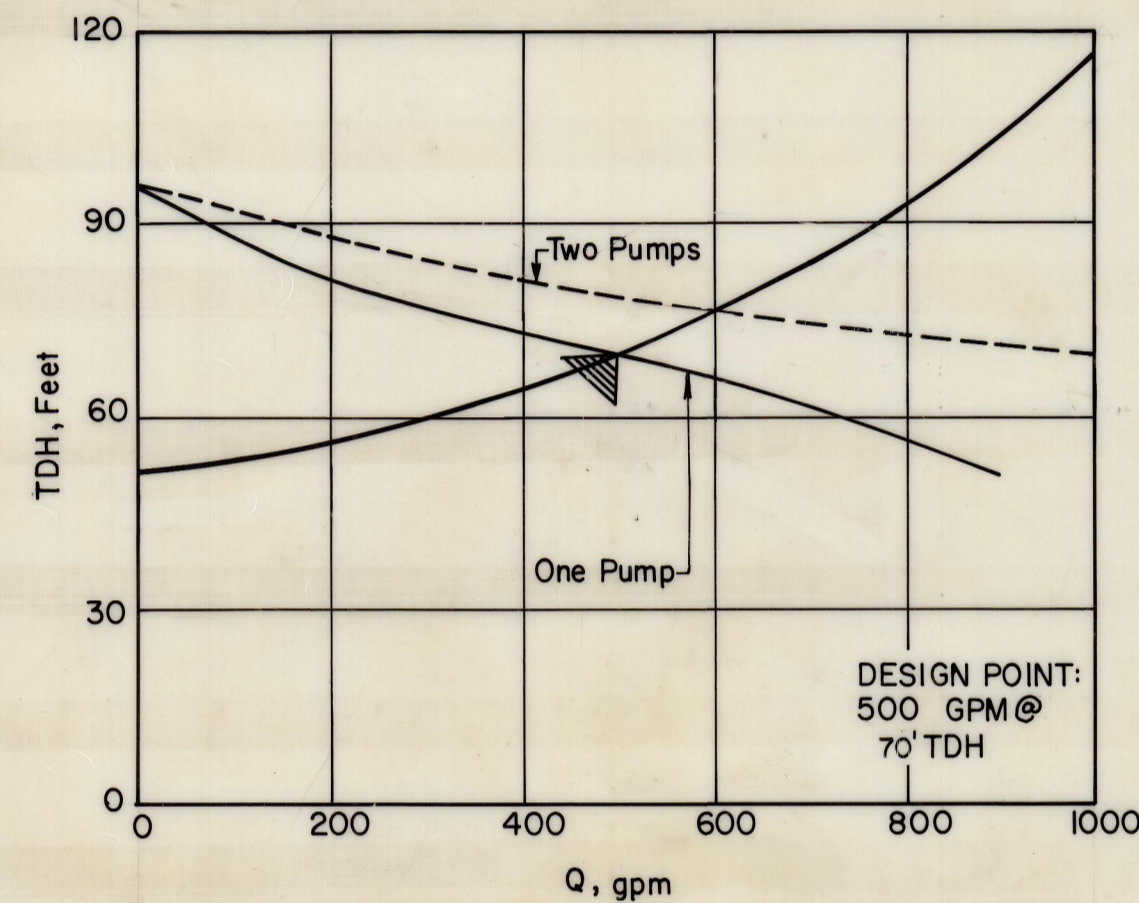


PUMPING STATION NO. 3-2

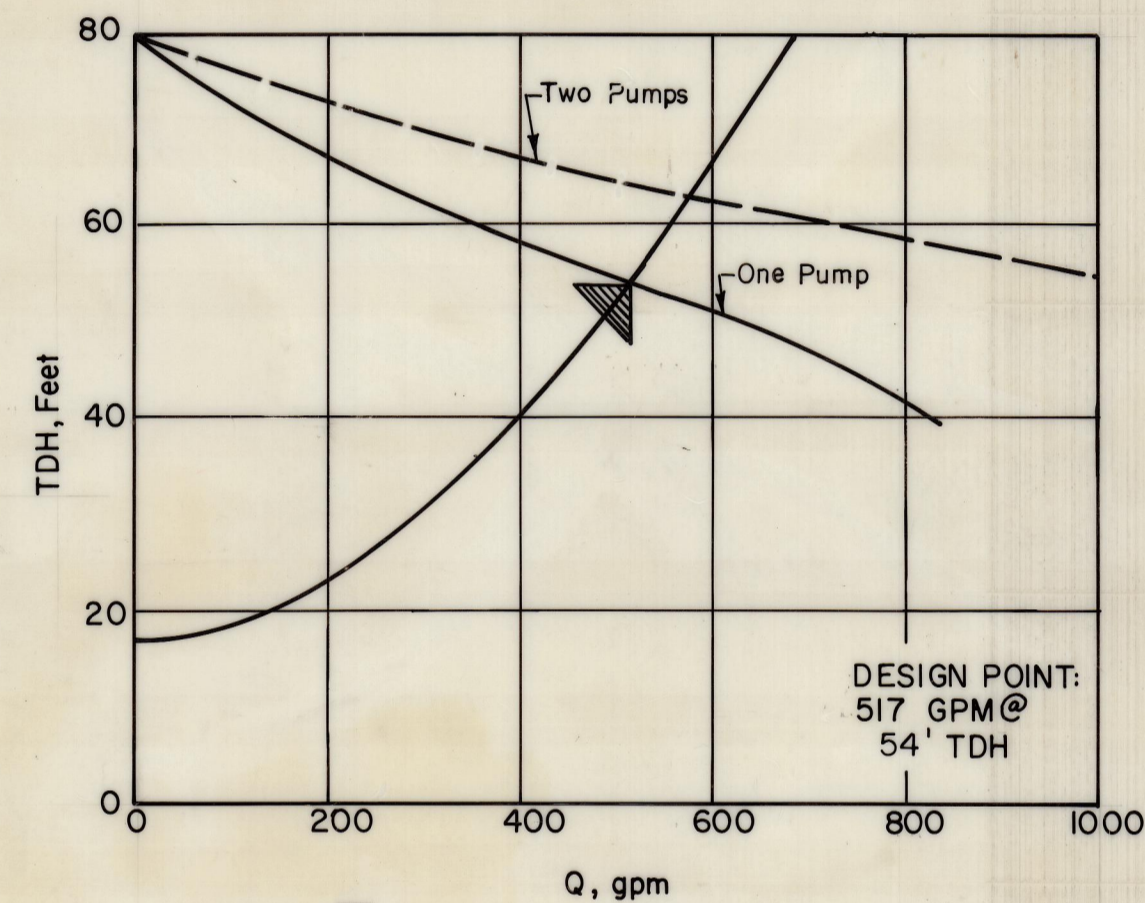


PUMPING STATION NO. 6-1

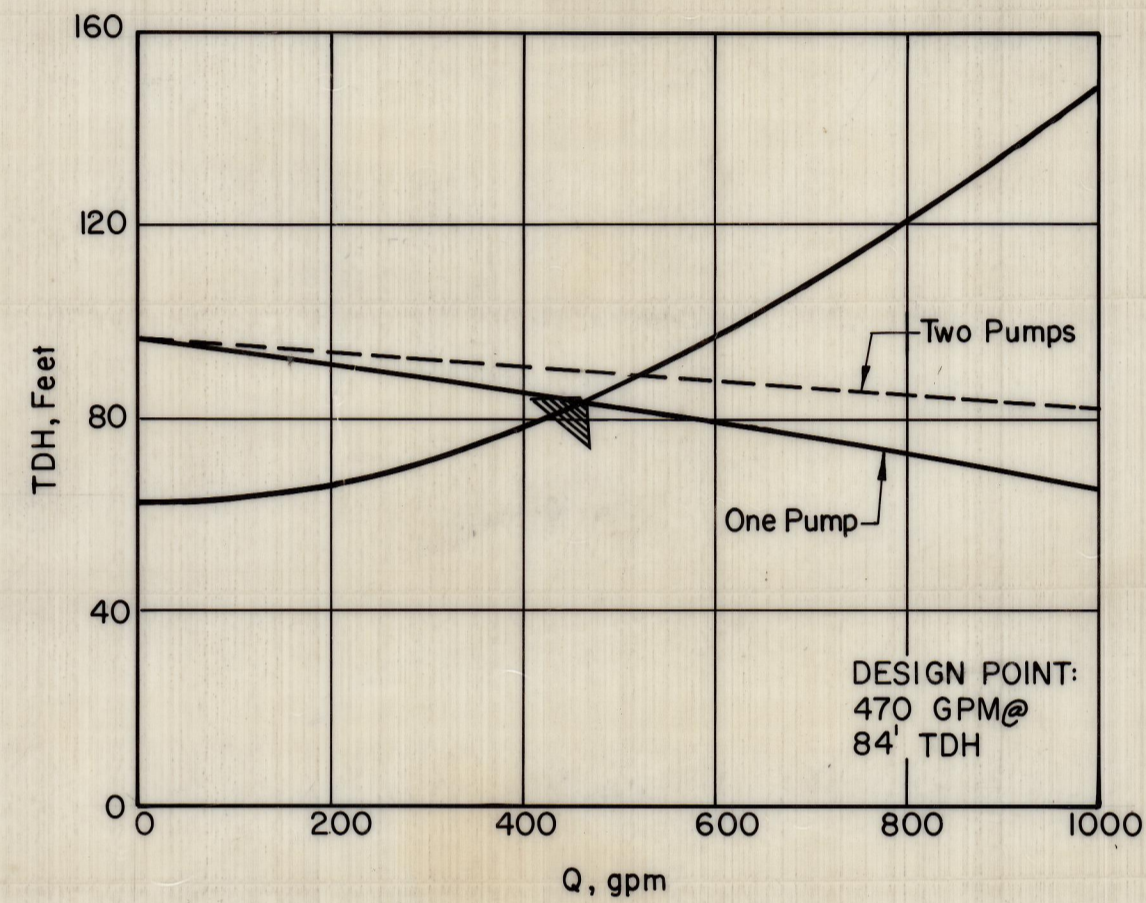


PUMPING STATION NO. 6-2

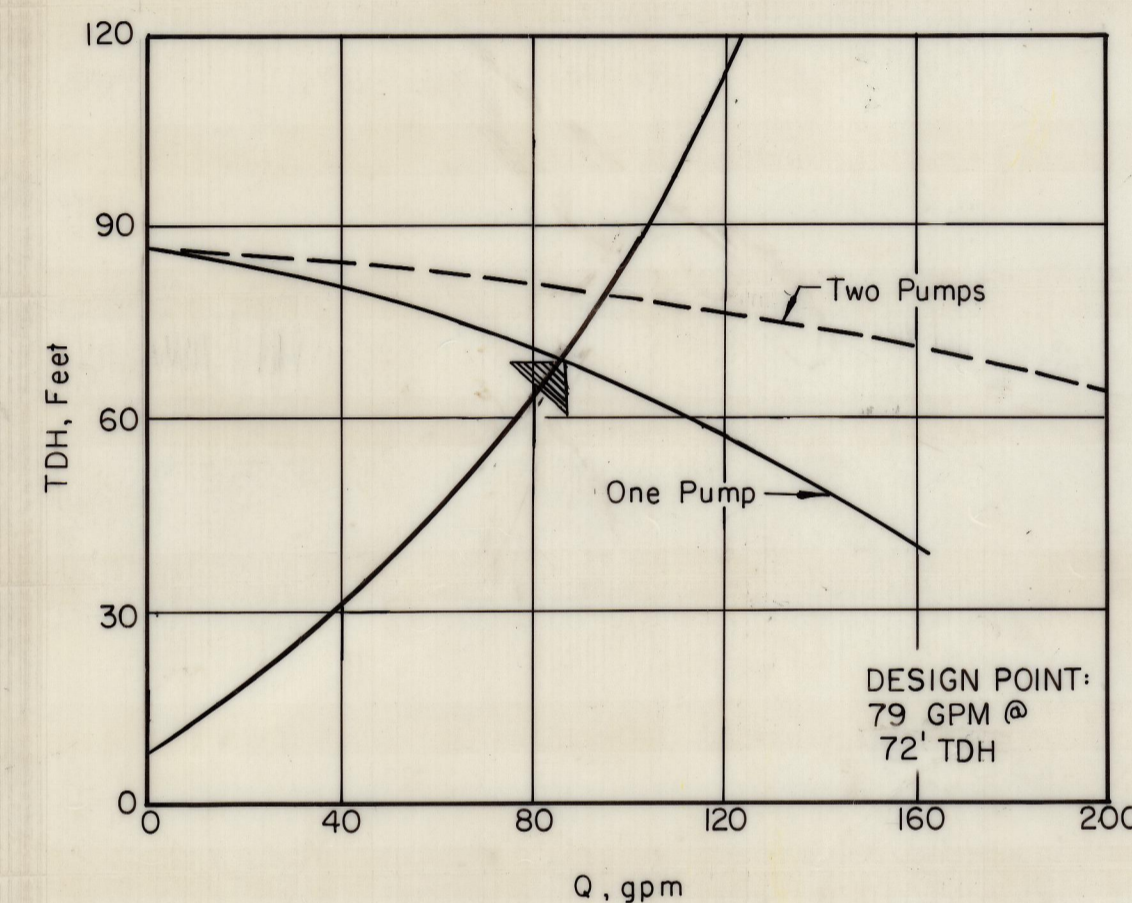


PUMPING STATION NO. 7-1

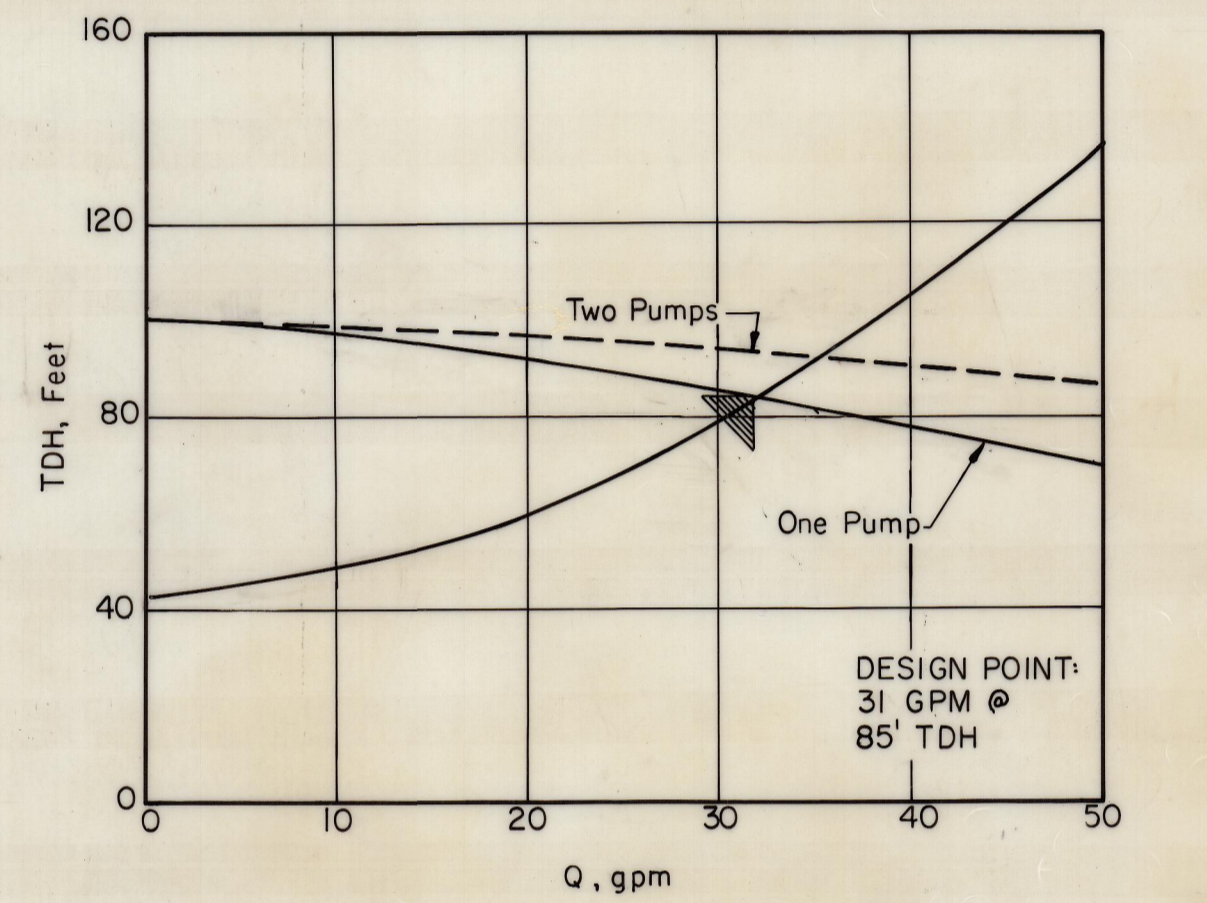

PUMPING STATION NO. 7-2

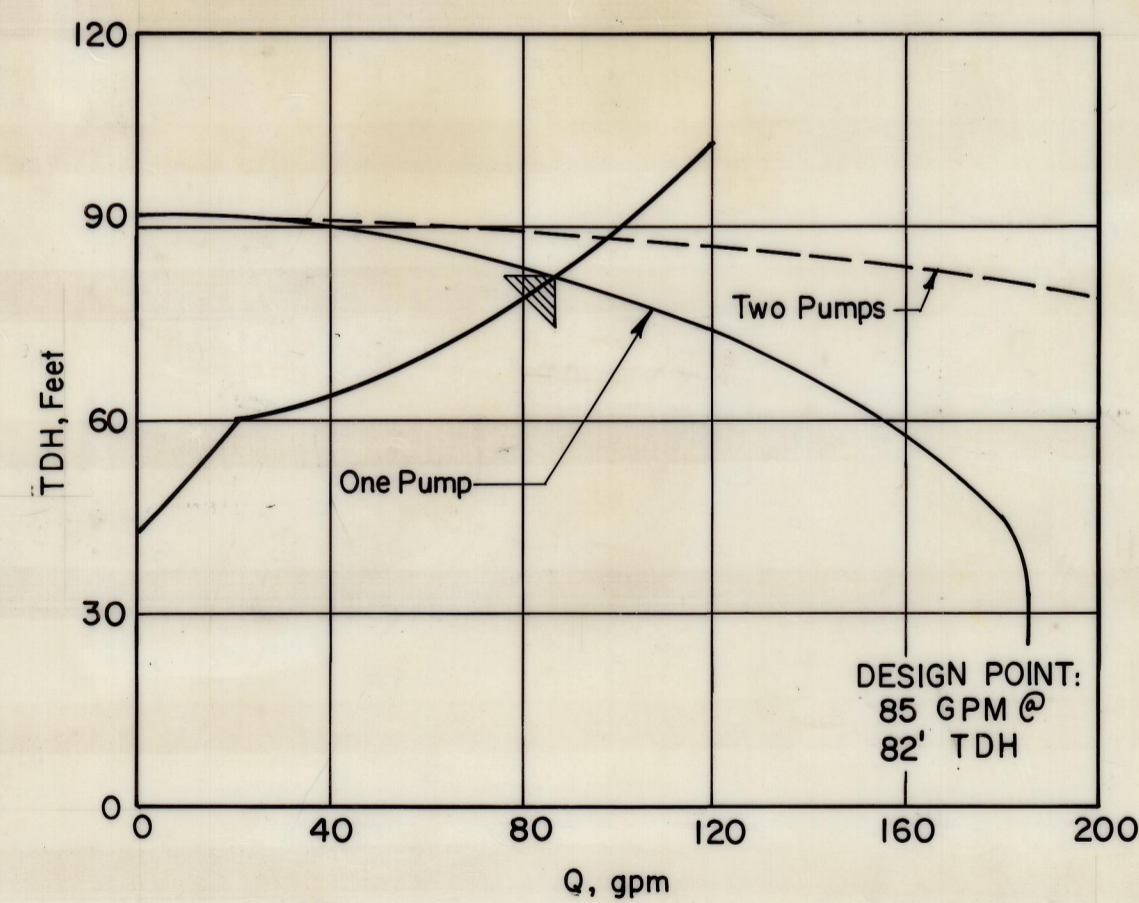

PUMPING STATION NO. 8-1

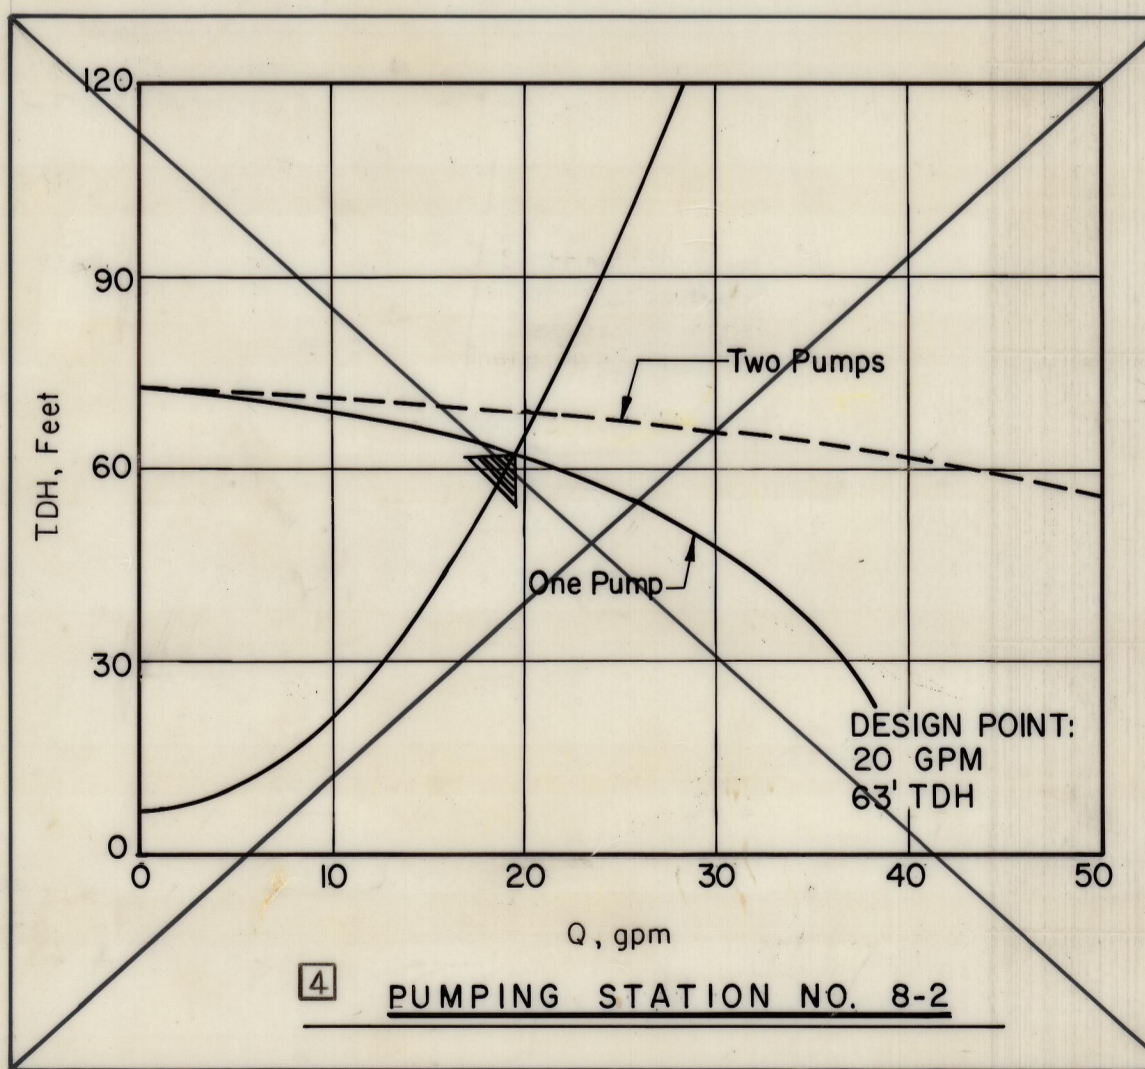

PUMPING STATION NO. 8-2



RUMMEL, KLEPPER & KAHL
CONSULTING ENGINEERS
BALTIMORE, MARYLAND

ENGINEER
REG. NO. 3381
DATE: FEB 25 1982
DESIGNED
DRAWN
CHECKED

PROJECT C-240565-03
DEEP CREEK LAKE SANITARY
DISTRICT SEWERAGE FACILITIES

CONTRACT NO. 10
PUMPING STATIONS

CONTRACT
DRAWINGS

ISSUED 12-2-82

NO.	DATE	REVISION	BY
4	5-25-85	Revised System Curve	T.N.L.
3	3-22-82	Revised System Curve	B.P.
2	5-11-82	Revised System Curve	B.P.
1	5-11-82	Revised System Curve	K.F.

DRAWING COMPLETED

SCALE	POSITION SHEET	SHEET NO.
AS SHOWN		8 OF 25